


3/26/2024 11:10:09 TEMPLATE VERSION: 3.4 AM

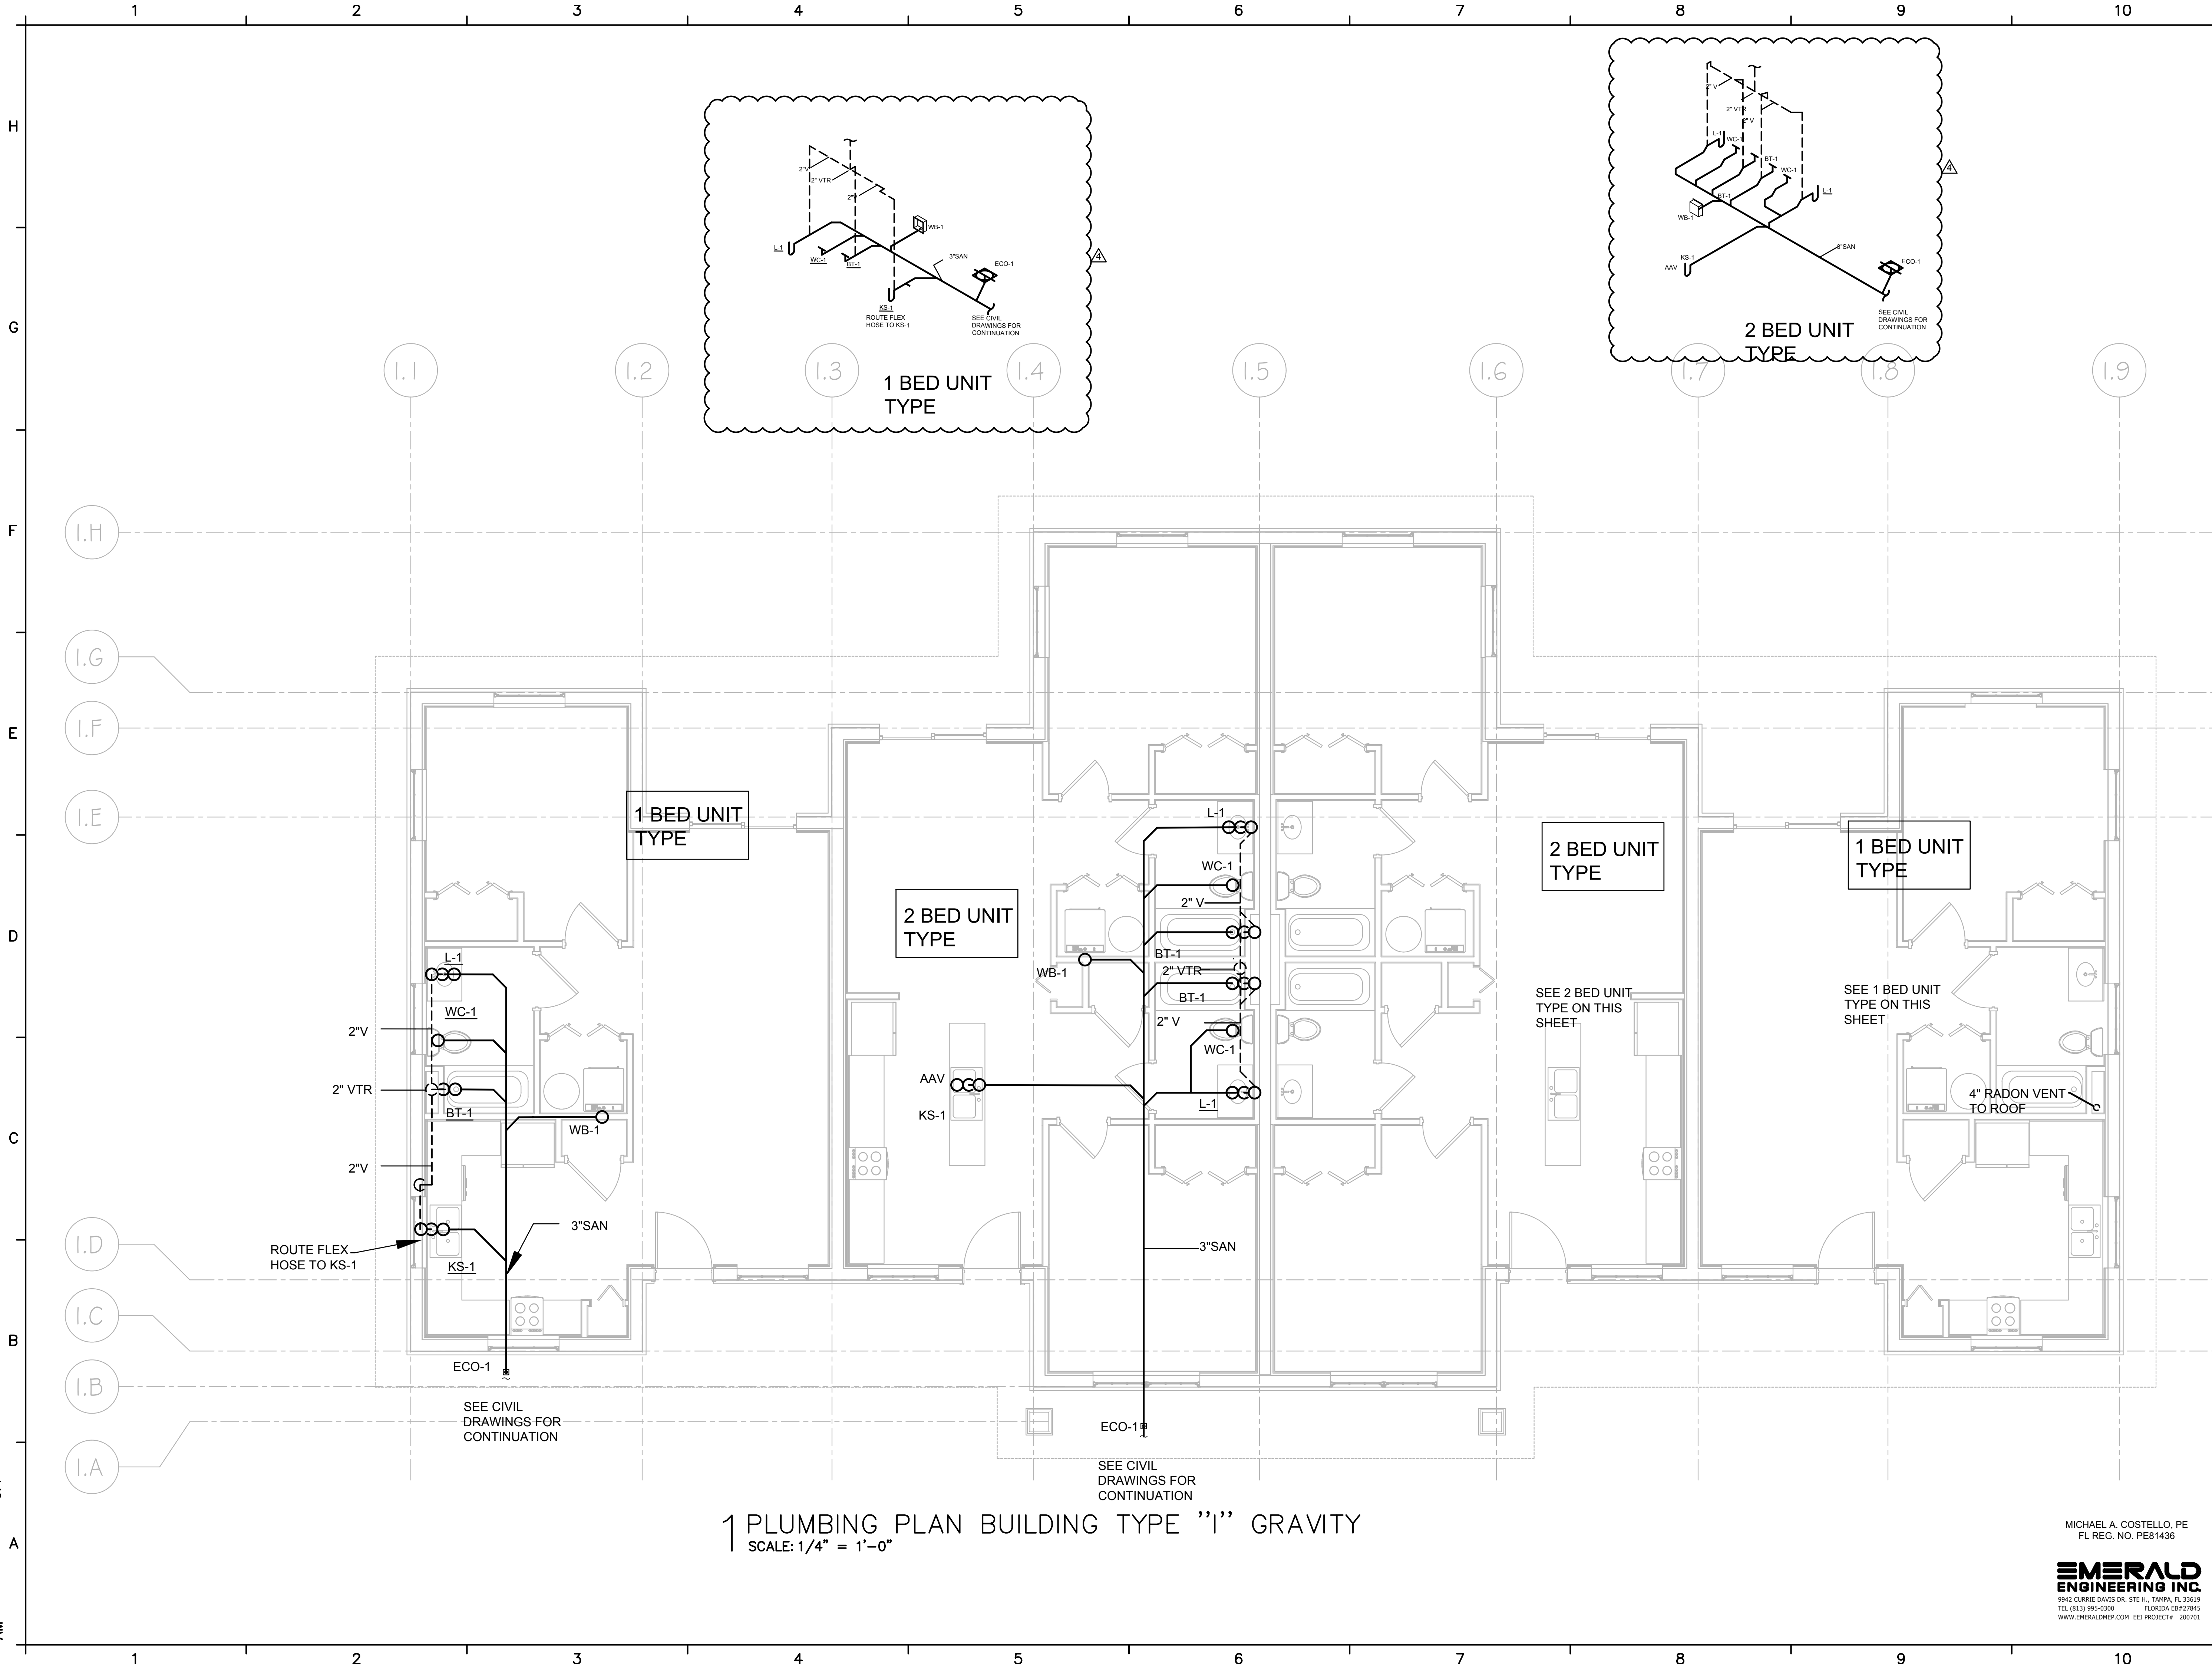

1 PLUMBING PLAN BUILDING TYPE "I" GRAVITY  
SCALE: 1/4" = 1'-0"

MICHAEL A. COSTELLO, PE  
FL REG. NO. PE81436

**EMERALD ENGINEERING INC.**  
9942 CURRIE DAVIS DR., STE. H., TAMPA, FL 33619  
TEL (813) 995-0300 FLORIDA 08423845  
WWW.EMERALDPE.COM EEE PROJECT# 200701

PLUMBING  
PLAN  
BUILDING  
TYPE "I"  
GRAVITY  
**P211**

MAGNOLIA OAKS  
PHASE 1 - WEST PARCEL  
7240 MASSACHUSETTS AVE  
NEW PORT RICHEY, FLORIDA

ISSUE DATE  
BID CONST DOCS 06/28/2022  
PERMIT SET 04/19/2024  
ADDENDUM #4 07/16/2024

250  
Tampa, FL  
813.678.2420  
G M C NETWORK . C O M

DRAWN BY: GMC  
CHECKED BY: GMC

**GMC**