

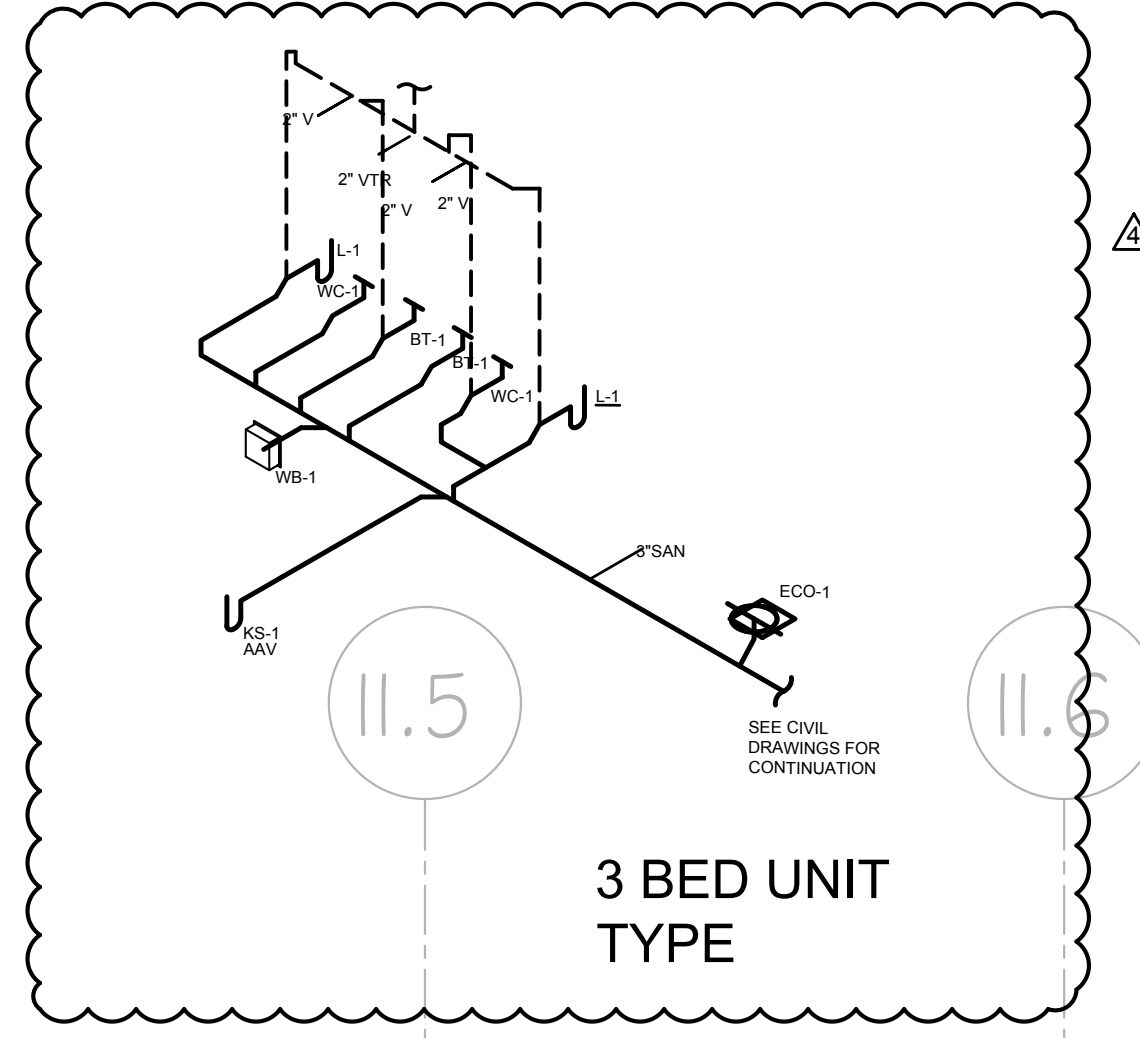


3/26/2024 11:10:09 TEMPLATE VERSION: 3.4 AM

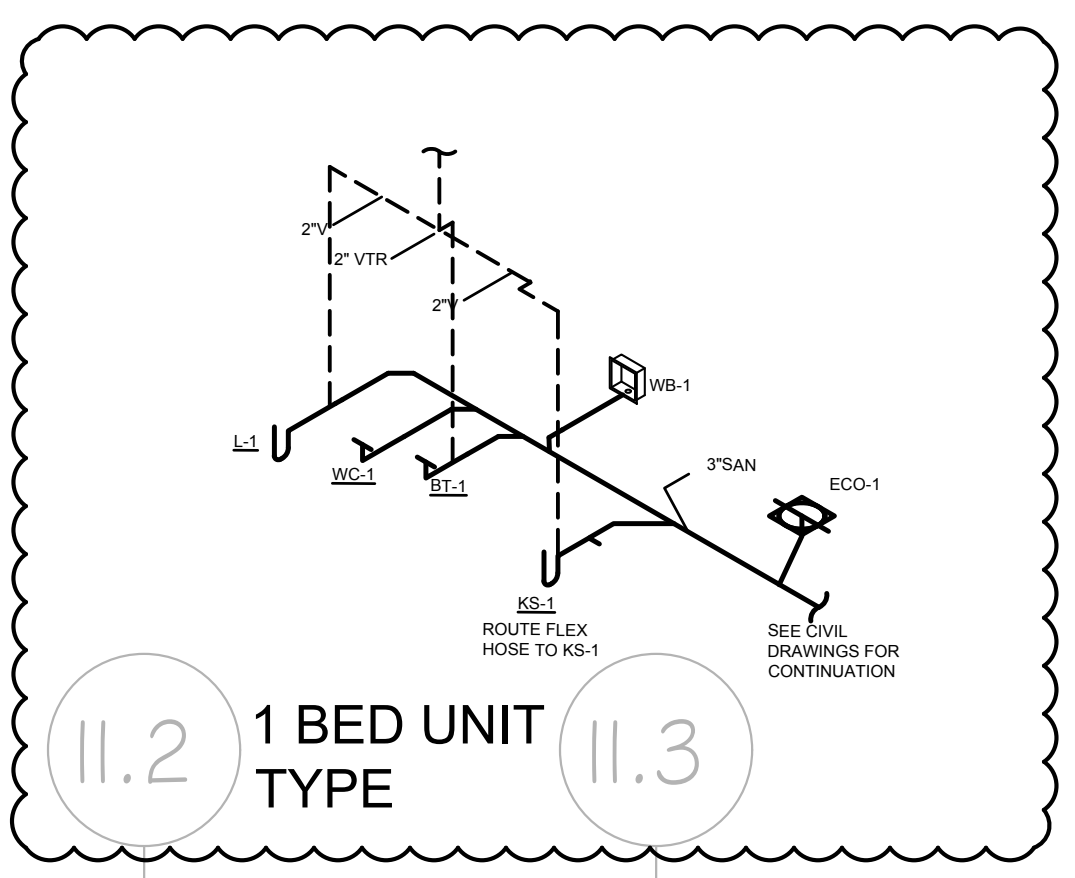

1 PLUMBING PLAN BUILDING TYPE "II" GRAVITY
SCALE: 1/4" = 1'-0"

MICHAEL A. COSTELLO, PE
FL REG. NO. PE81436
EMERALD ENGINEERING INC.
9942 CURRIE DAVIS DR. STE. H., TAMPA, FL 33619
TEL (813) 995-0300 FLORIDA 08423945
WWW.EMERALDPEP.COM EEP PROJECT# 200701

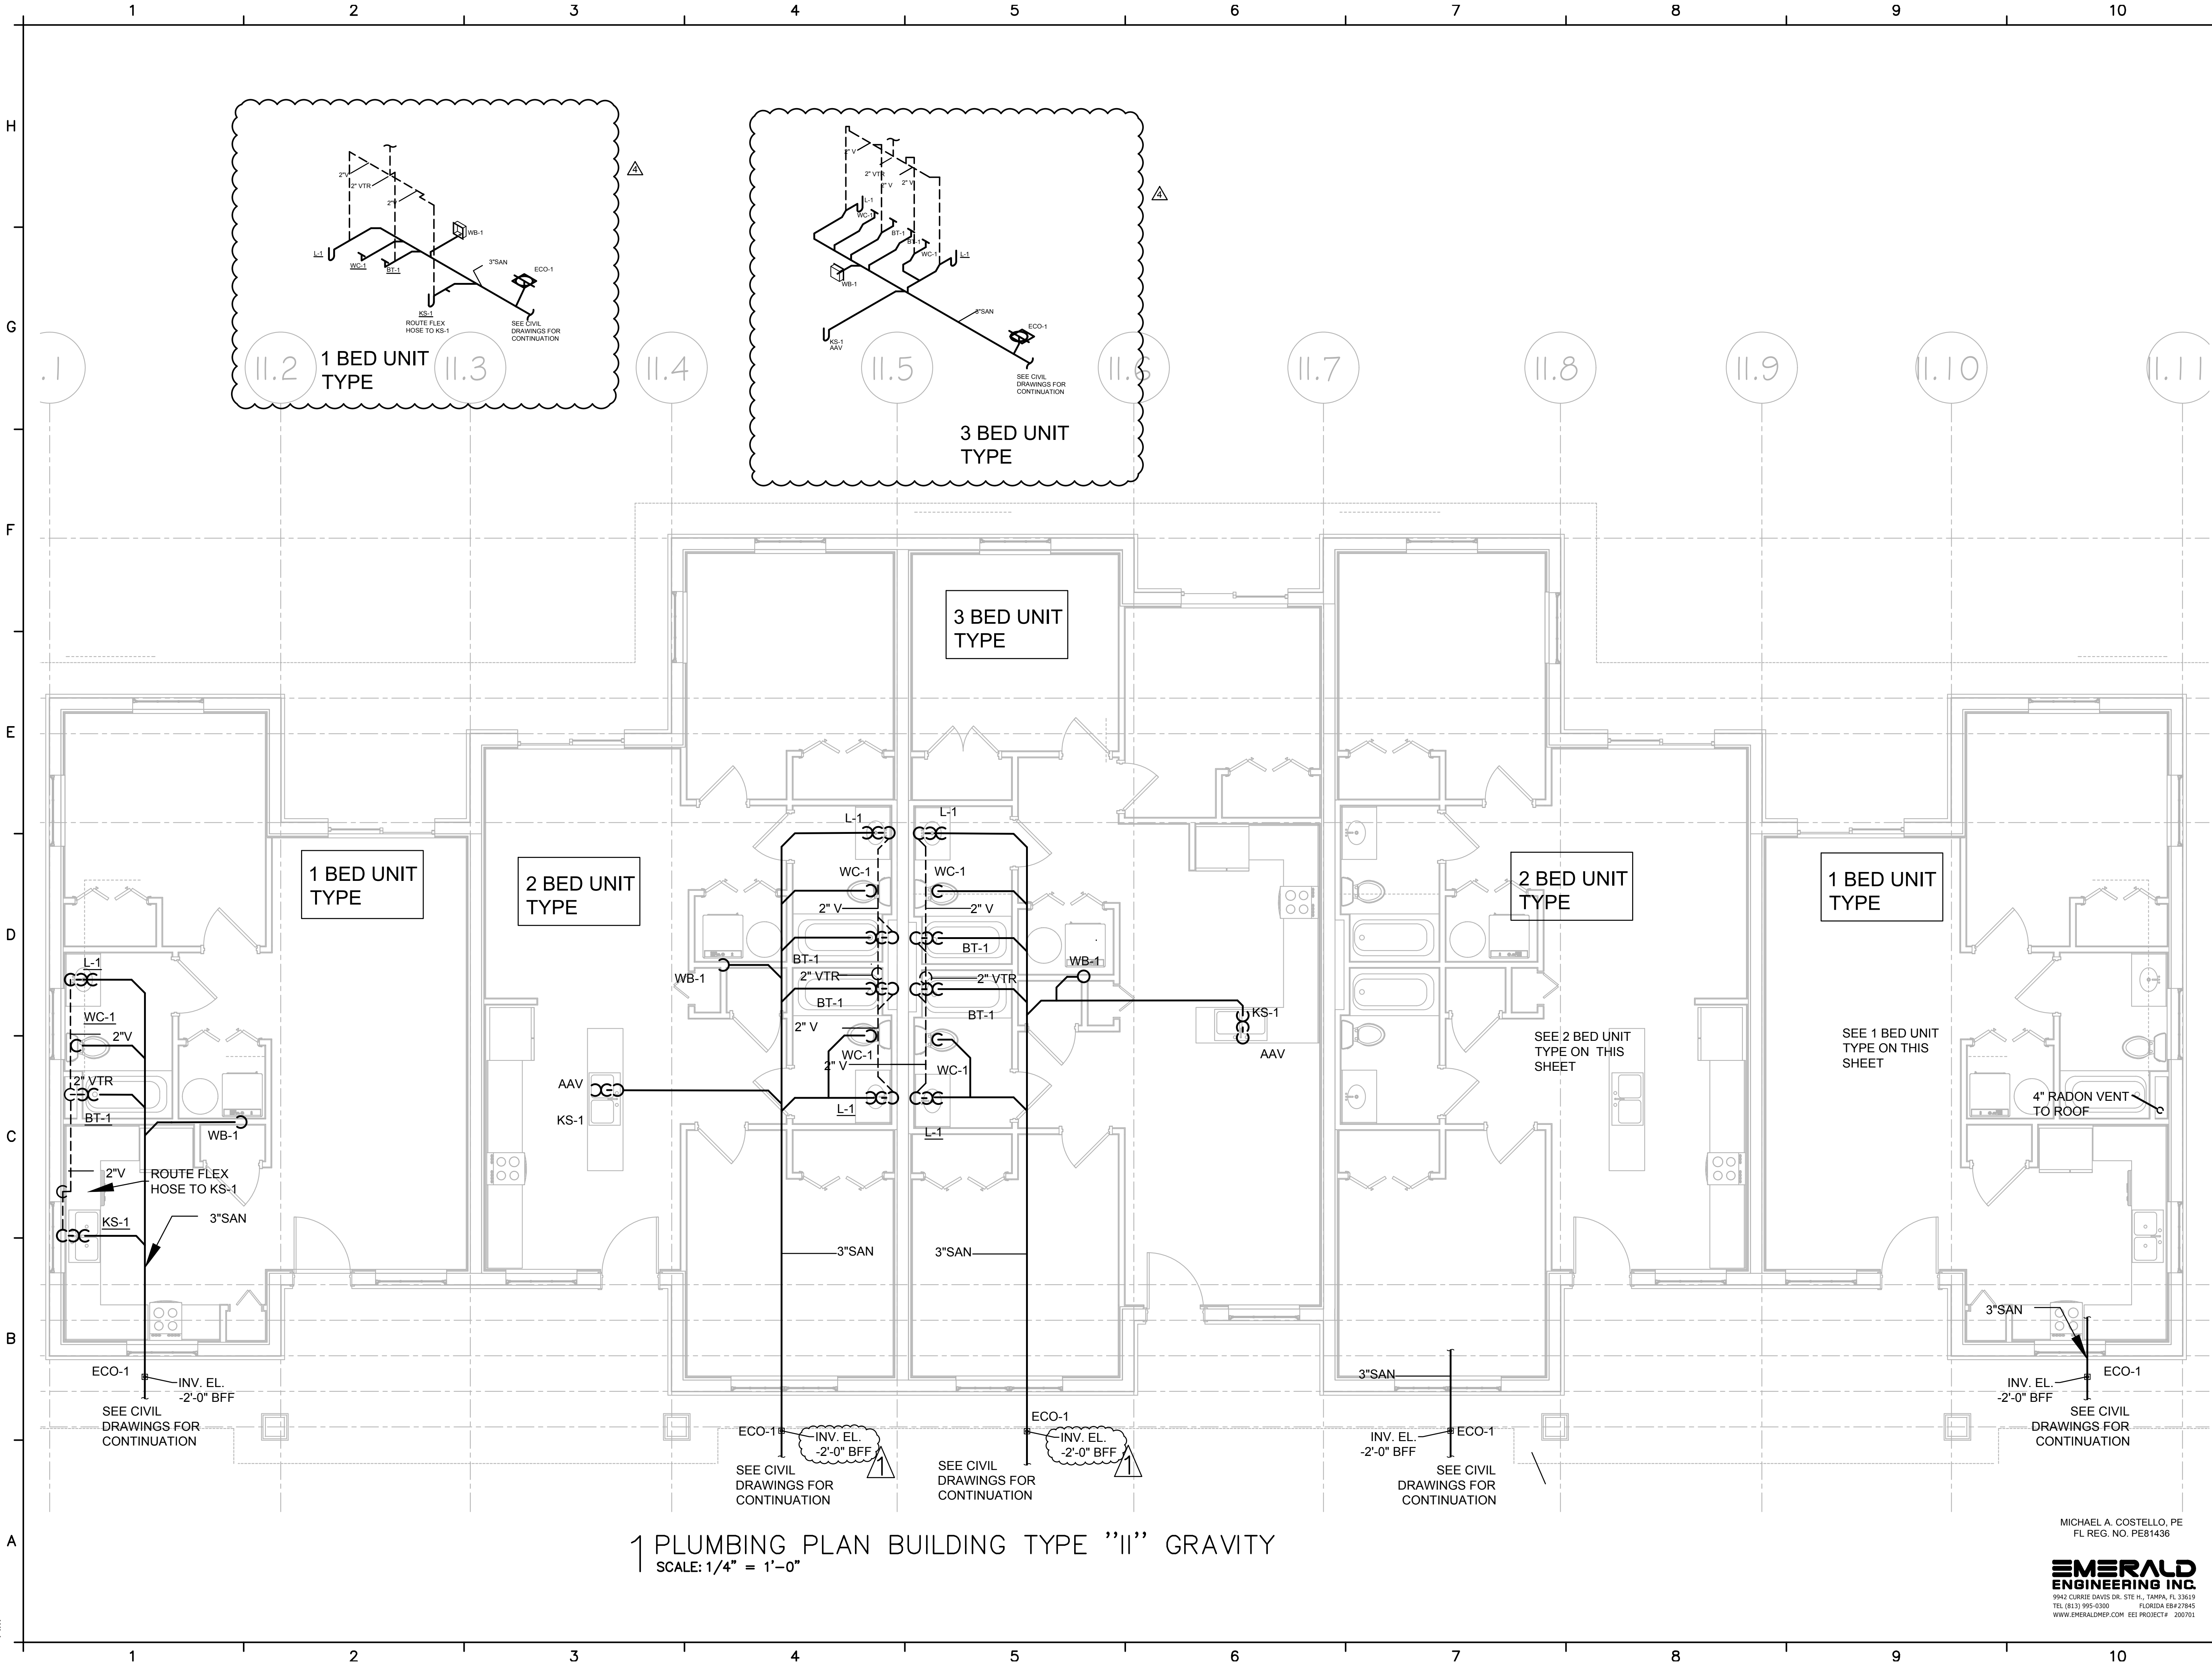

MAGNOLIA OAKS
PHASE 1 - WEST PARCEL
7240 MASSACHUSETTS AVE
NEW PORT RICHEY, FLORIDA

ISSUE DATE
BID CONST DOCS 06/28/2022
PERMIT SET 04/19/2024
REVISED PLUMBING 07/26/2022 01
ADDENDUM #4 07/16/2022 050

Tampa, FL
33602
813.678.2420
GMC NETWORK . COM

DRAWN BY: GMC
CHECKED BY: GMC

PLUMBING PLAN
BUILDING TYPE
"II" GRAVITY
P212