


3/26/2024 11:10:09 TEMPLATE VERSION:
3.4
AM

1 2 3 4 5 6 7 8 9 10


H
G
F
E
D
C
B
A

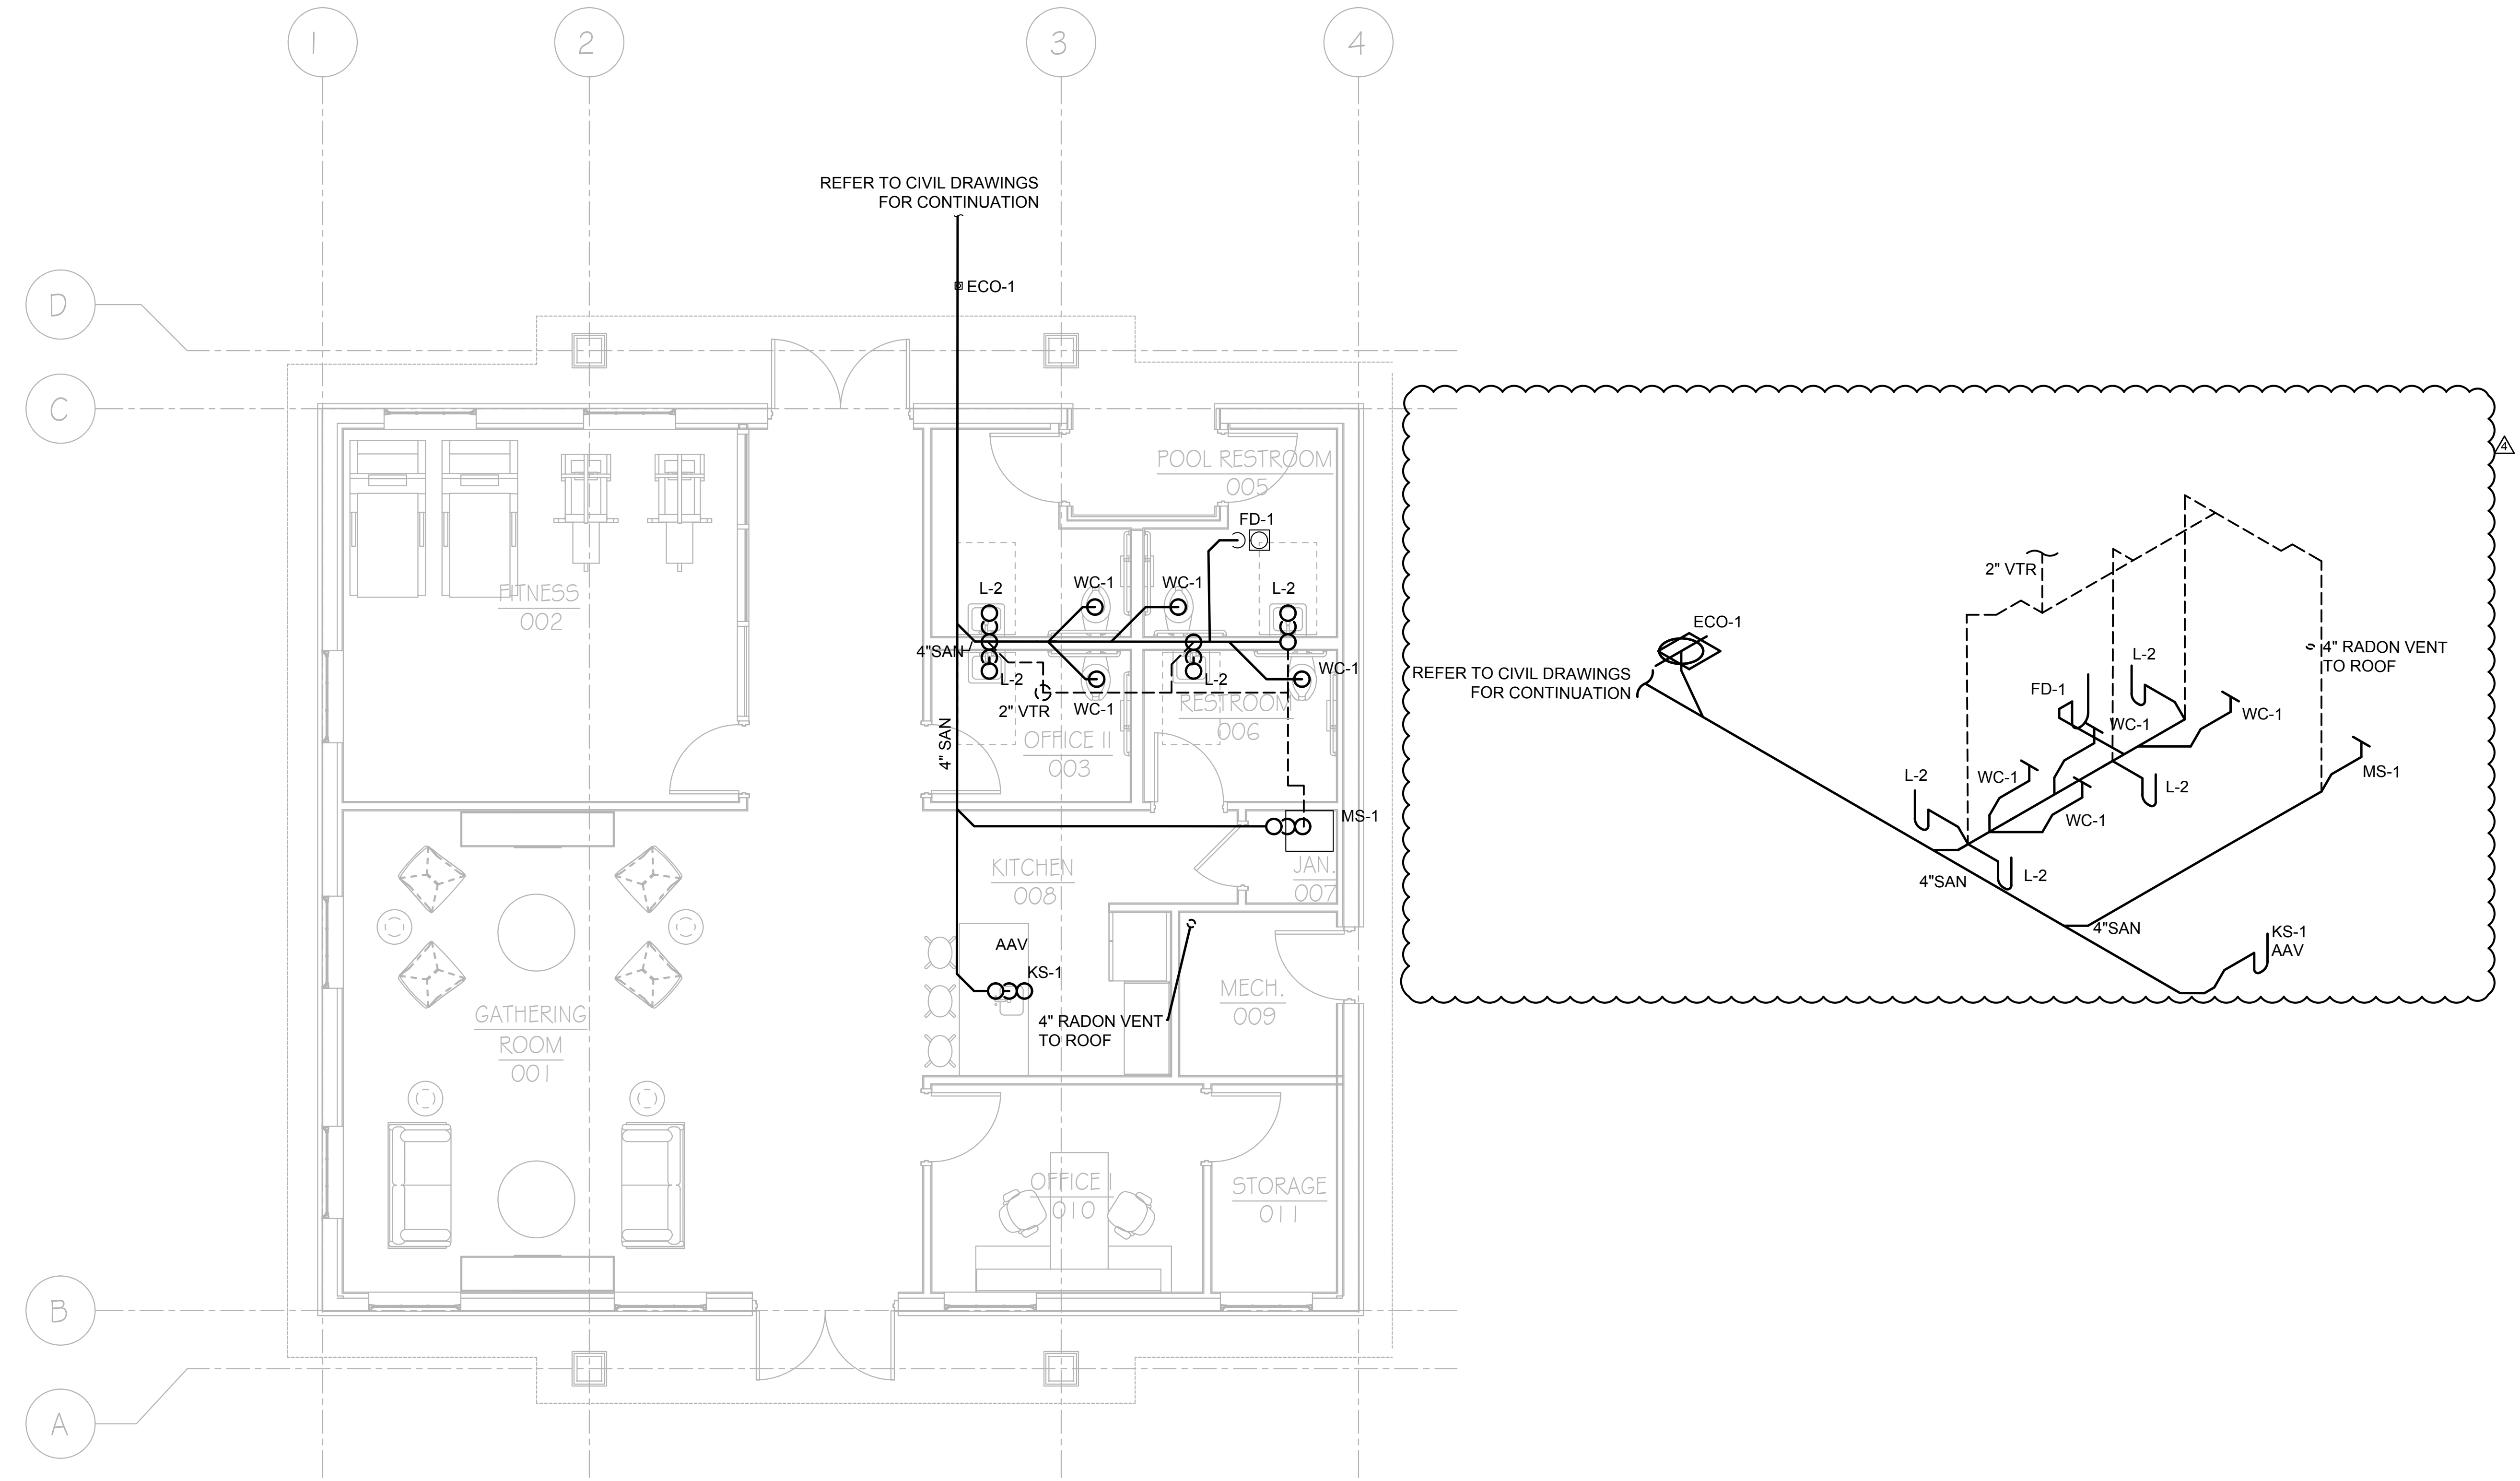

1 PLUMBING PLAN CLUBHOUSE GRAVITY
SCALE: 1/4" = 1'-0"

MICHAEL A. COSTELLO, PE
FL REG. NO. PE81436

EMERALD ENGINEERING INC.
9942 CURRIE DAVIS DR. STE H., TAMPA, FL 33619
TEL (813) 995-0300 FLORIDA 08423845
WWW.EMERALDMEP.COM EEE PROJECT# 200701

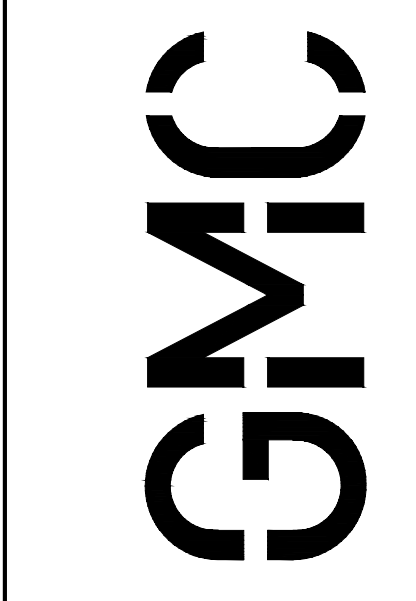

ISSUE DATE
BID CONST DOCS 06/28/2022
PERMIT SET 04/19/2024
ADDENDUM # 07/16/2024 201 North Franklin Street, Suite 250 Tampa, FL 33602 813.678.2420 G M C NETWORK . C O M

DRAWN BY: GMC
CHECKED BY: GMC

MAGNOLIA OAKS
PHASE 1 - WEST PARCEL
7240 MASSACHUSETTS AVE
NEW PORT RICHEY, FLORIDA

FL REG. NO. PE81436
MICHAEL A. COSTELLO, PE

PLUMBING PLAN CLUBHOUSE GRAVITY
P215

H
G
F
E
D
C
B
A

1 2 3 4 5 6 7 8 9 10